







ROOF PLAN
SCALE 1:200@A1

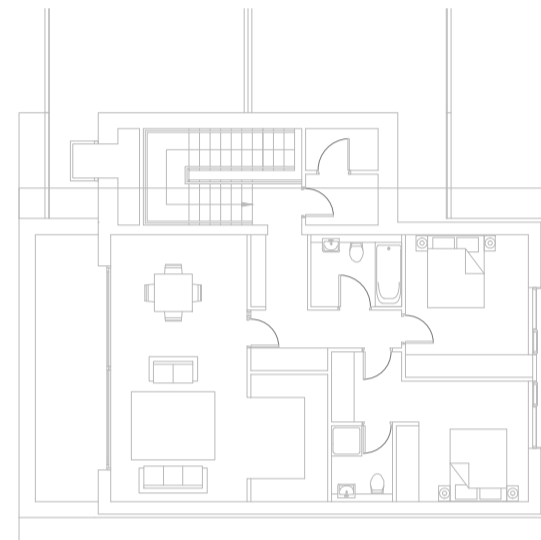

SECOND FLOOR PLAN
SCALE 1:200@A1

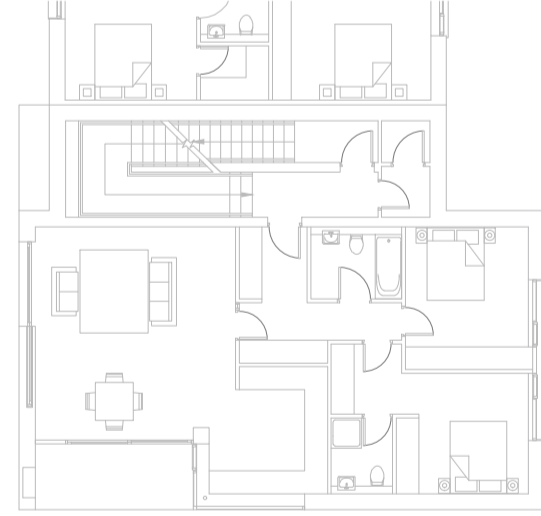


FIRST FLOOR PLAN
SCALE 1:200@A1

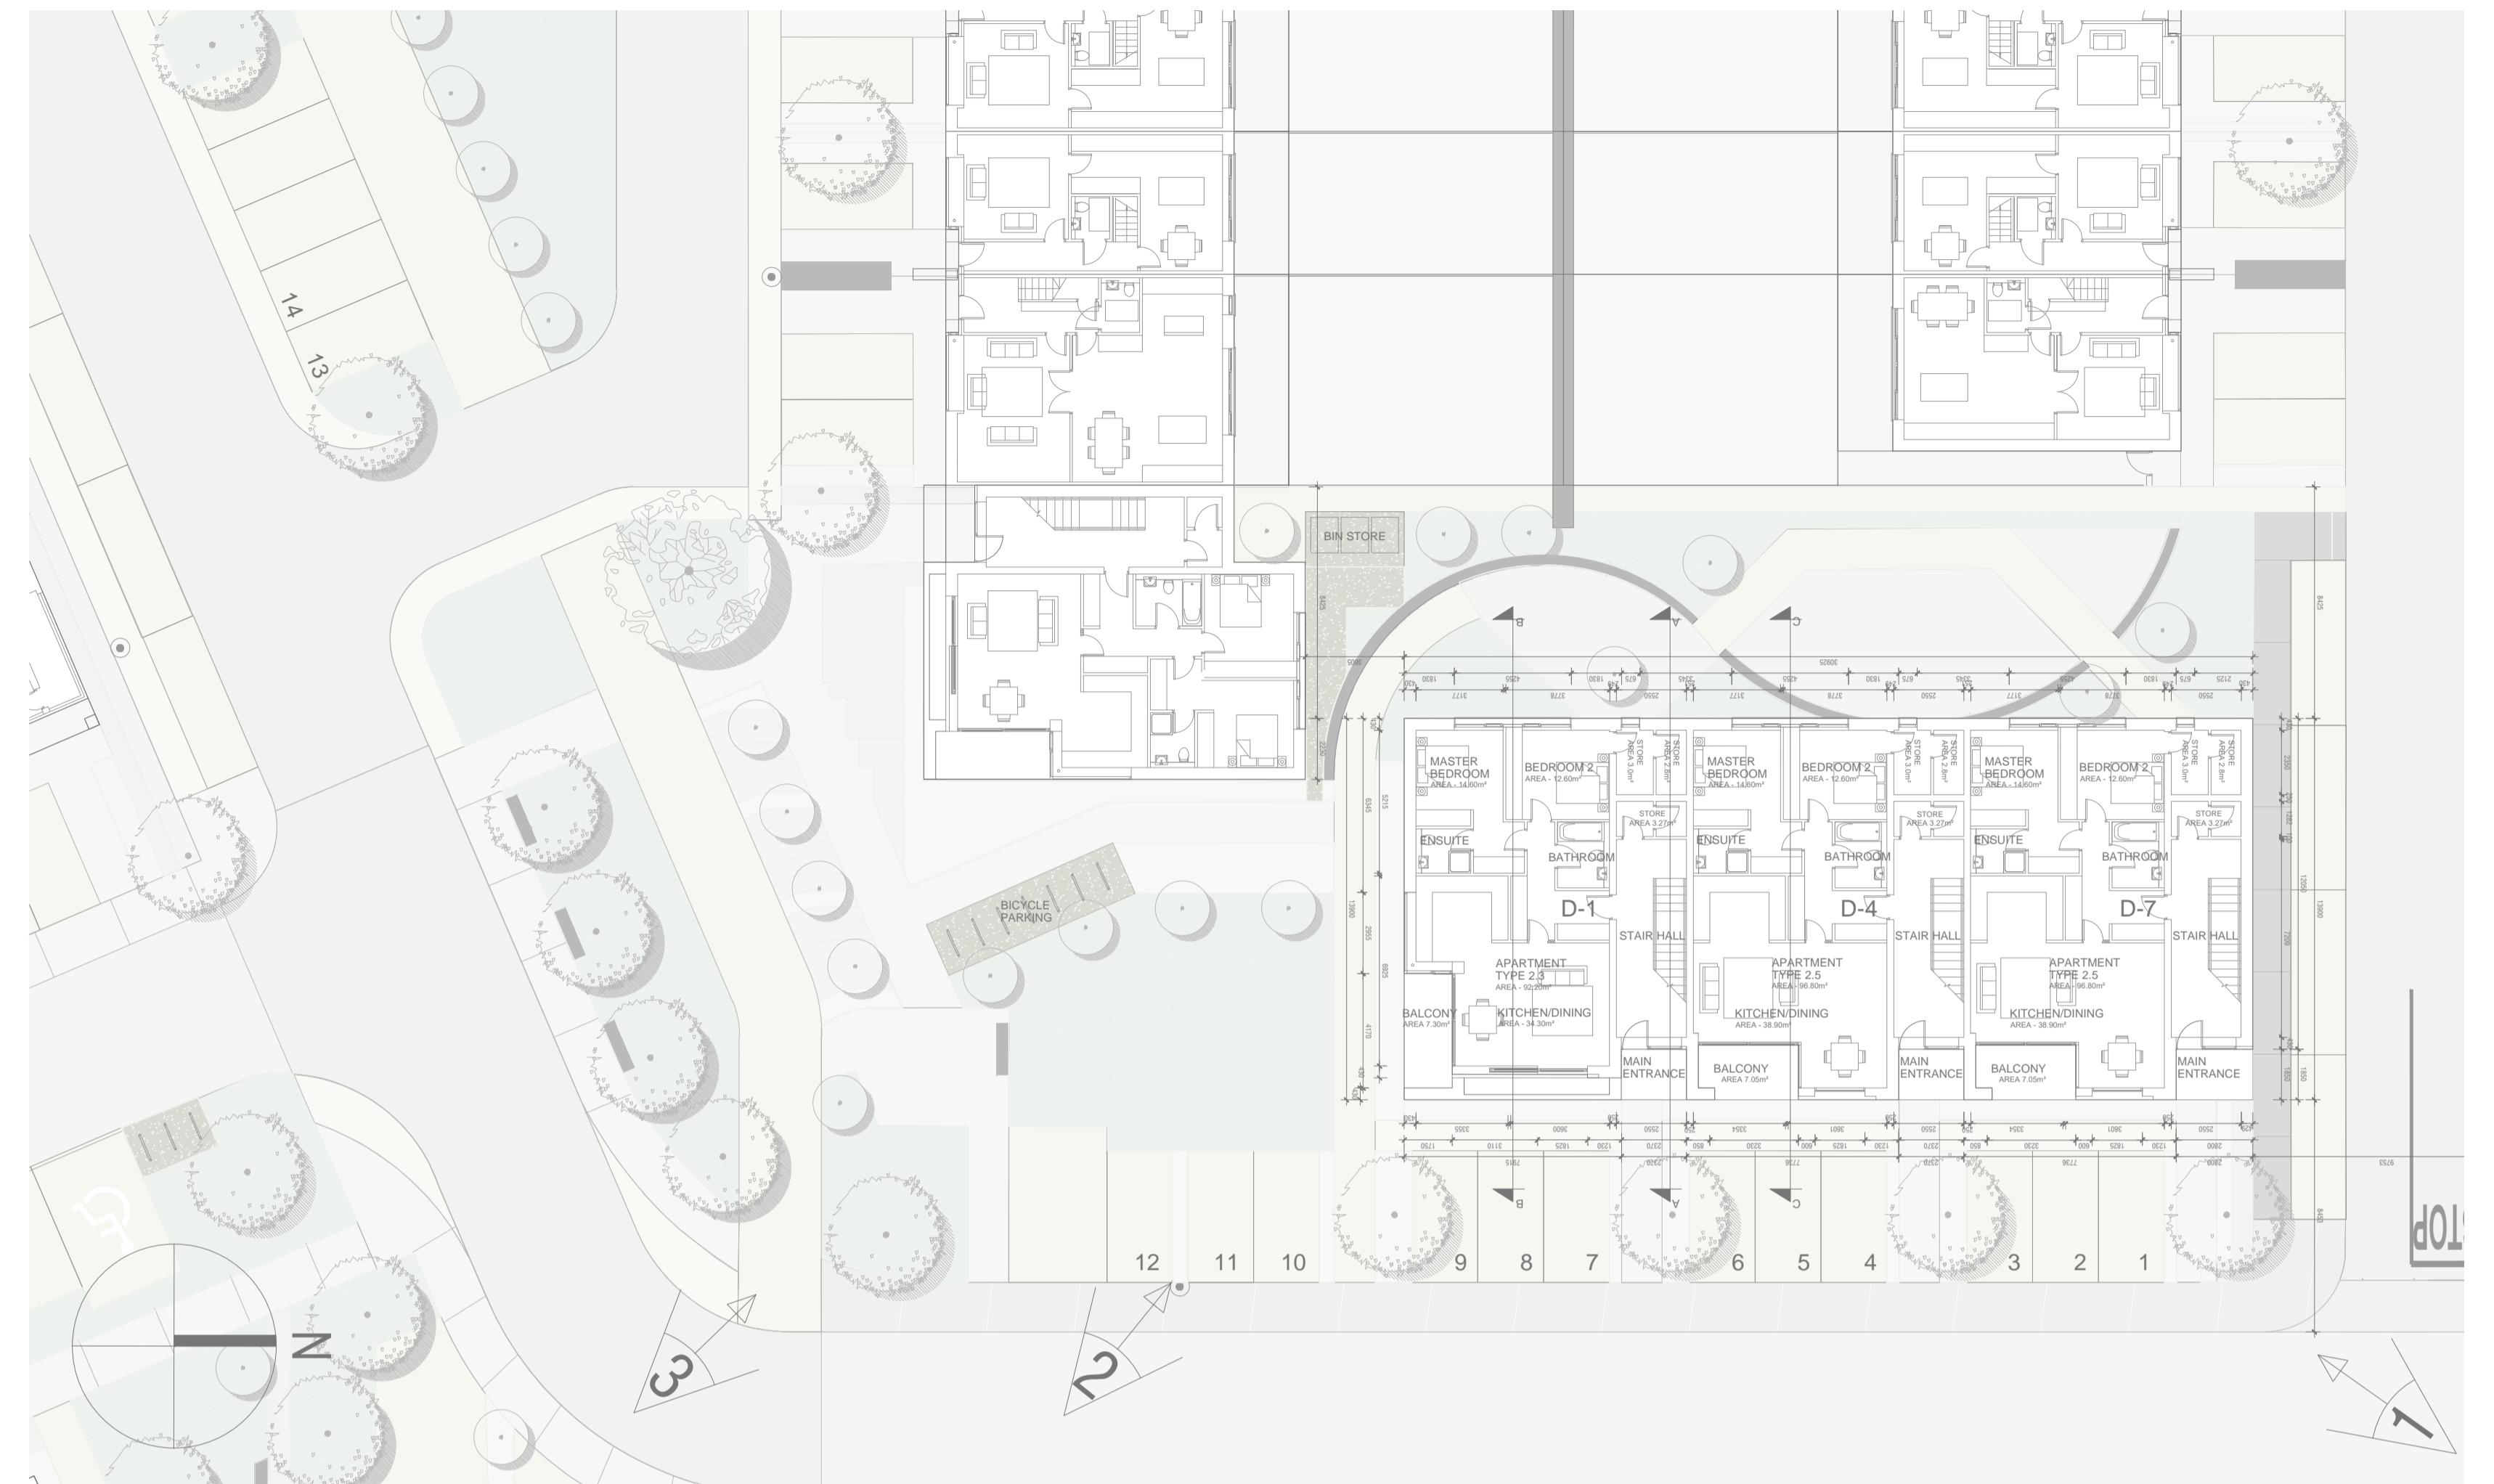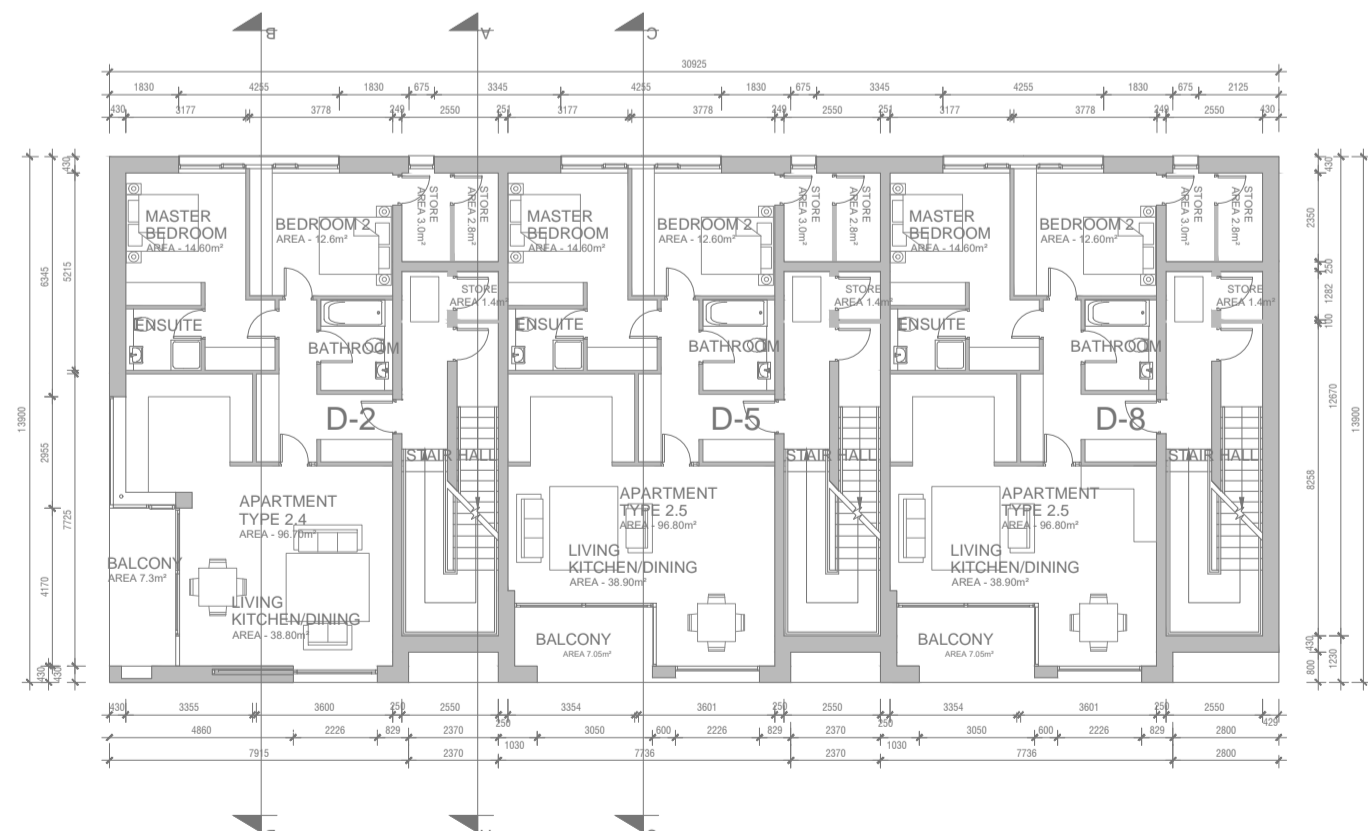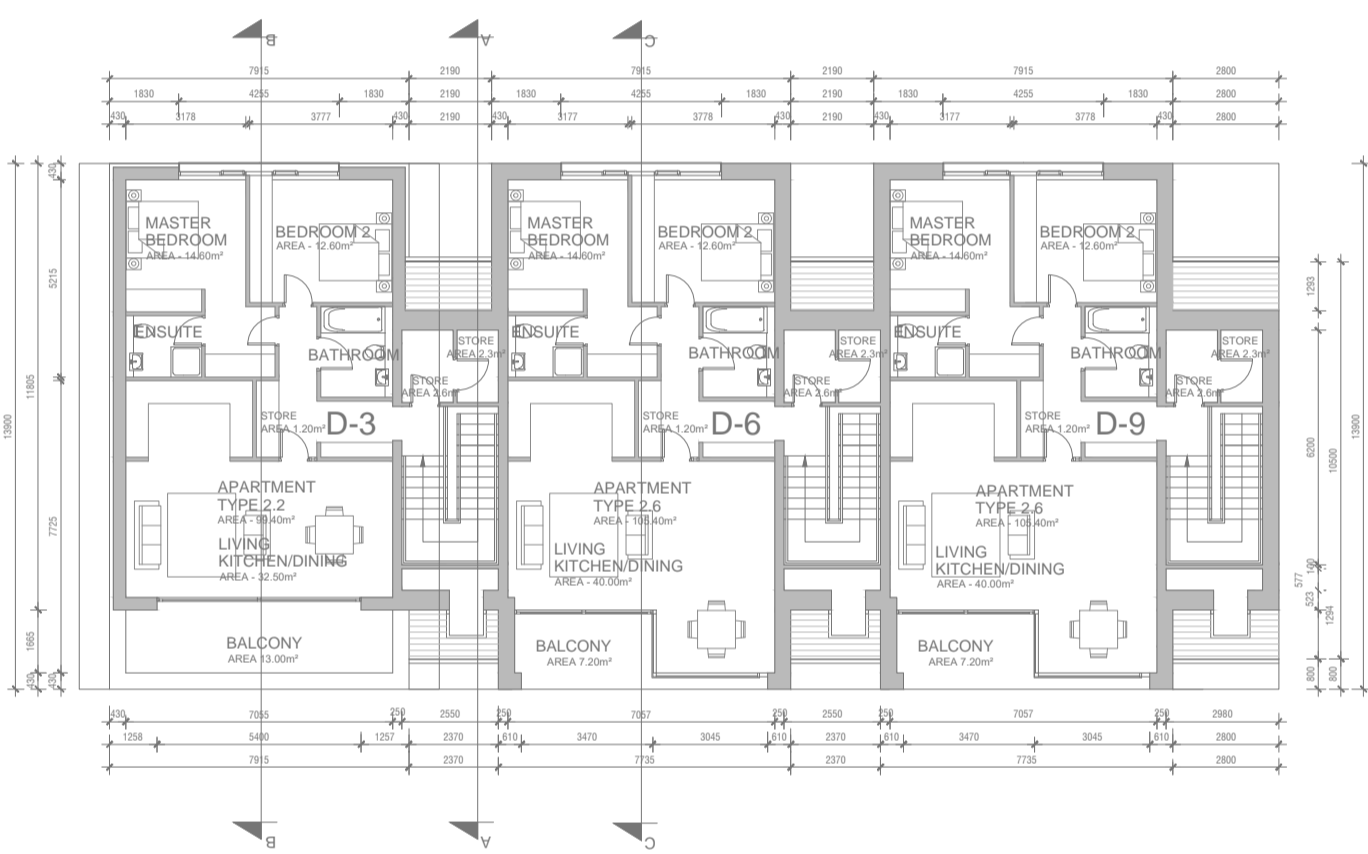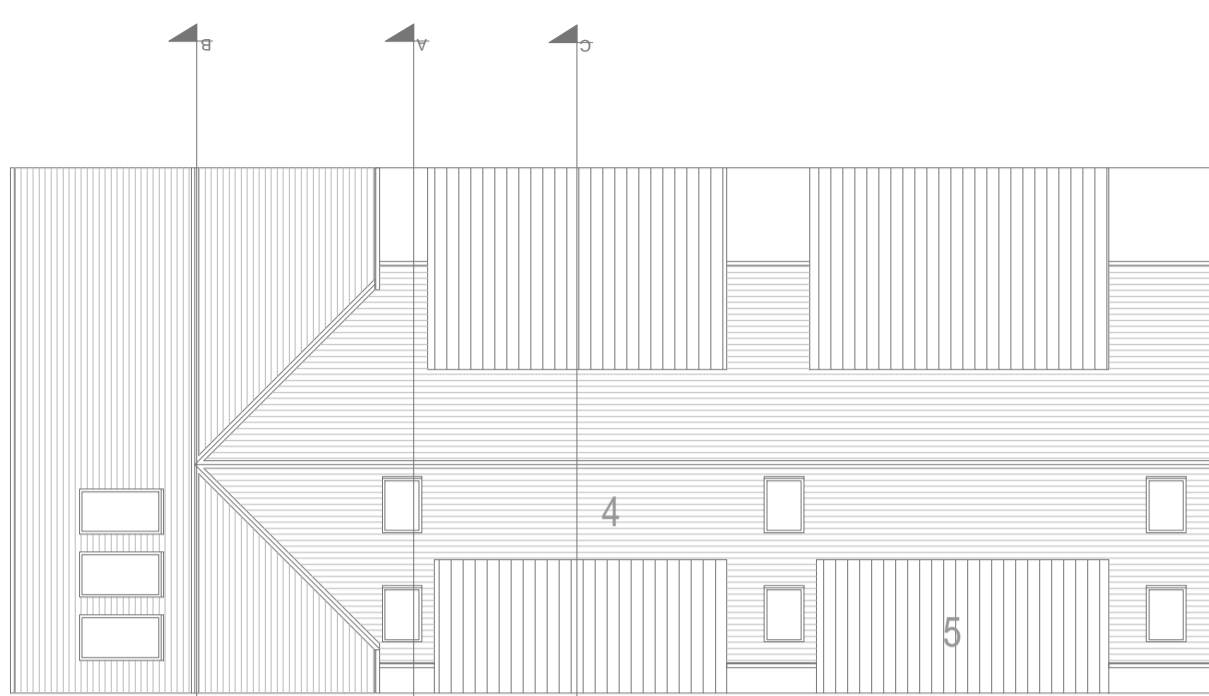

GROUND FLOOR PLAN
SCALE 1:200@A1

- BLOCK D - 9 UNITS
- APARTMENT TYPE 2.2
 - APARTMENT TYPE 2.3
 - APARTMENT TYPE 2.4
 - APARTMENT TYPE 2.5
 - APARTMENT TYPE 2.6
- 1 UNIT @ 99.40 m²
 - 1 UNIT @ 92.20 m²
 - 1 UNIT @ 96.70 m²
 - 4 UNITS @ 96.80 m²
 - 2 UNITS @ 105.40 m²

LEGEND
N.T.S.

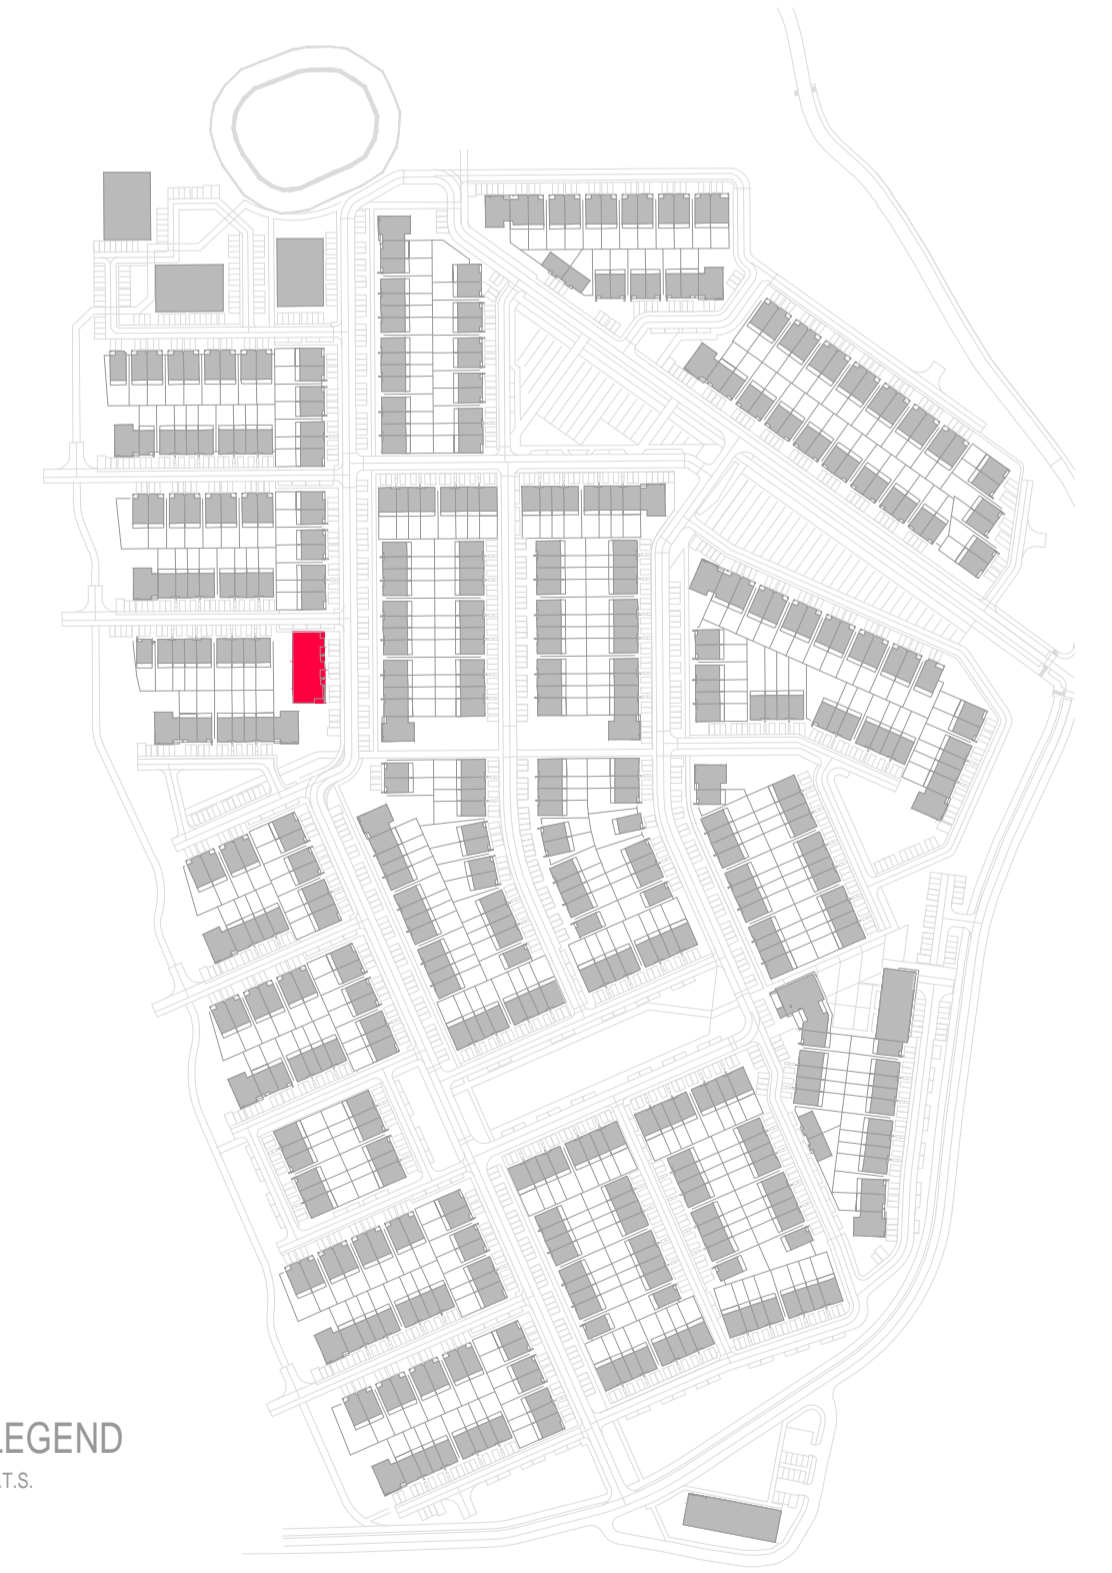

PROPOSED APARTMENT BLOCK - TYPE D PLANS

- NOTES
- Copyright Reserved.
 - Work to figured dimensions only. Do not scale drawing.
 - The contractor is responsible for checking all levels and dimension on site and shall refer all discrepancies to the Architect.
 - Where appropriate, for details of R.C. structure, or mechanical and electrical details, see Engineers drawings.
 - Proprietary items shall be fixed in strict accordance with manufacturers instructions.
 - Sizes of proprietary items shall be checked with manufacturer.
 - The contractor shall be responsible for the co-ordination of structure, finishes and services.

No.	Date	Revision	Initials	No.	Date	Revision	Initials	No.	Date	Revision	Initials

Project : RATHMULLAN	JOB NO. 17/094
Client : TRAILFORD LTD	
Drawing Title : PROP. APARTMENT BLK - TYPE D PLANS	DRAWING NO. PP-A3-01
Date : Aug 2019 Scale as shown	Checked by: JOL
File :	Revision No. B
Niall D. Brennan Associates, 52 Pembroke Road, Ballsbridge, Dublin 4, Ireland	
TEL (353 1) 478 90 09 FAX (353 1) 478 90 10 E-MAIL info@ndba.ie WEB www.ndba.ie	

